

 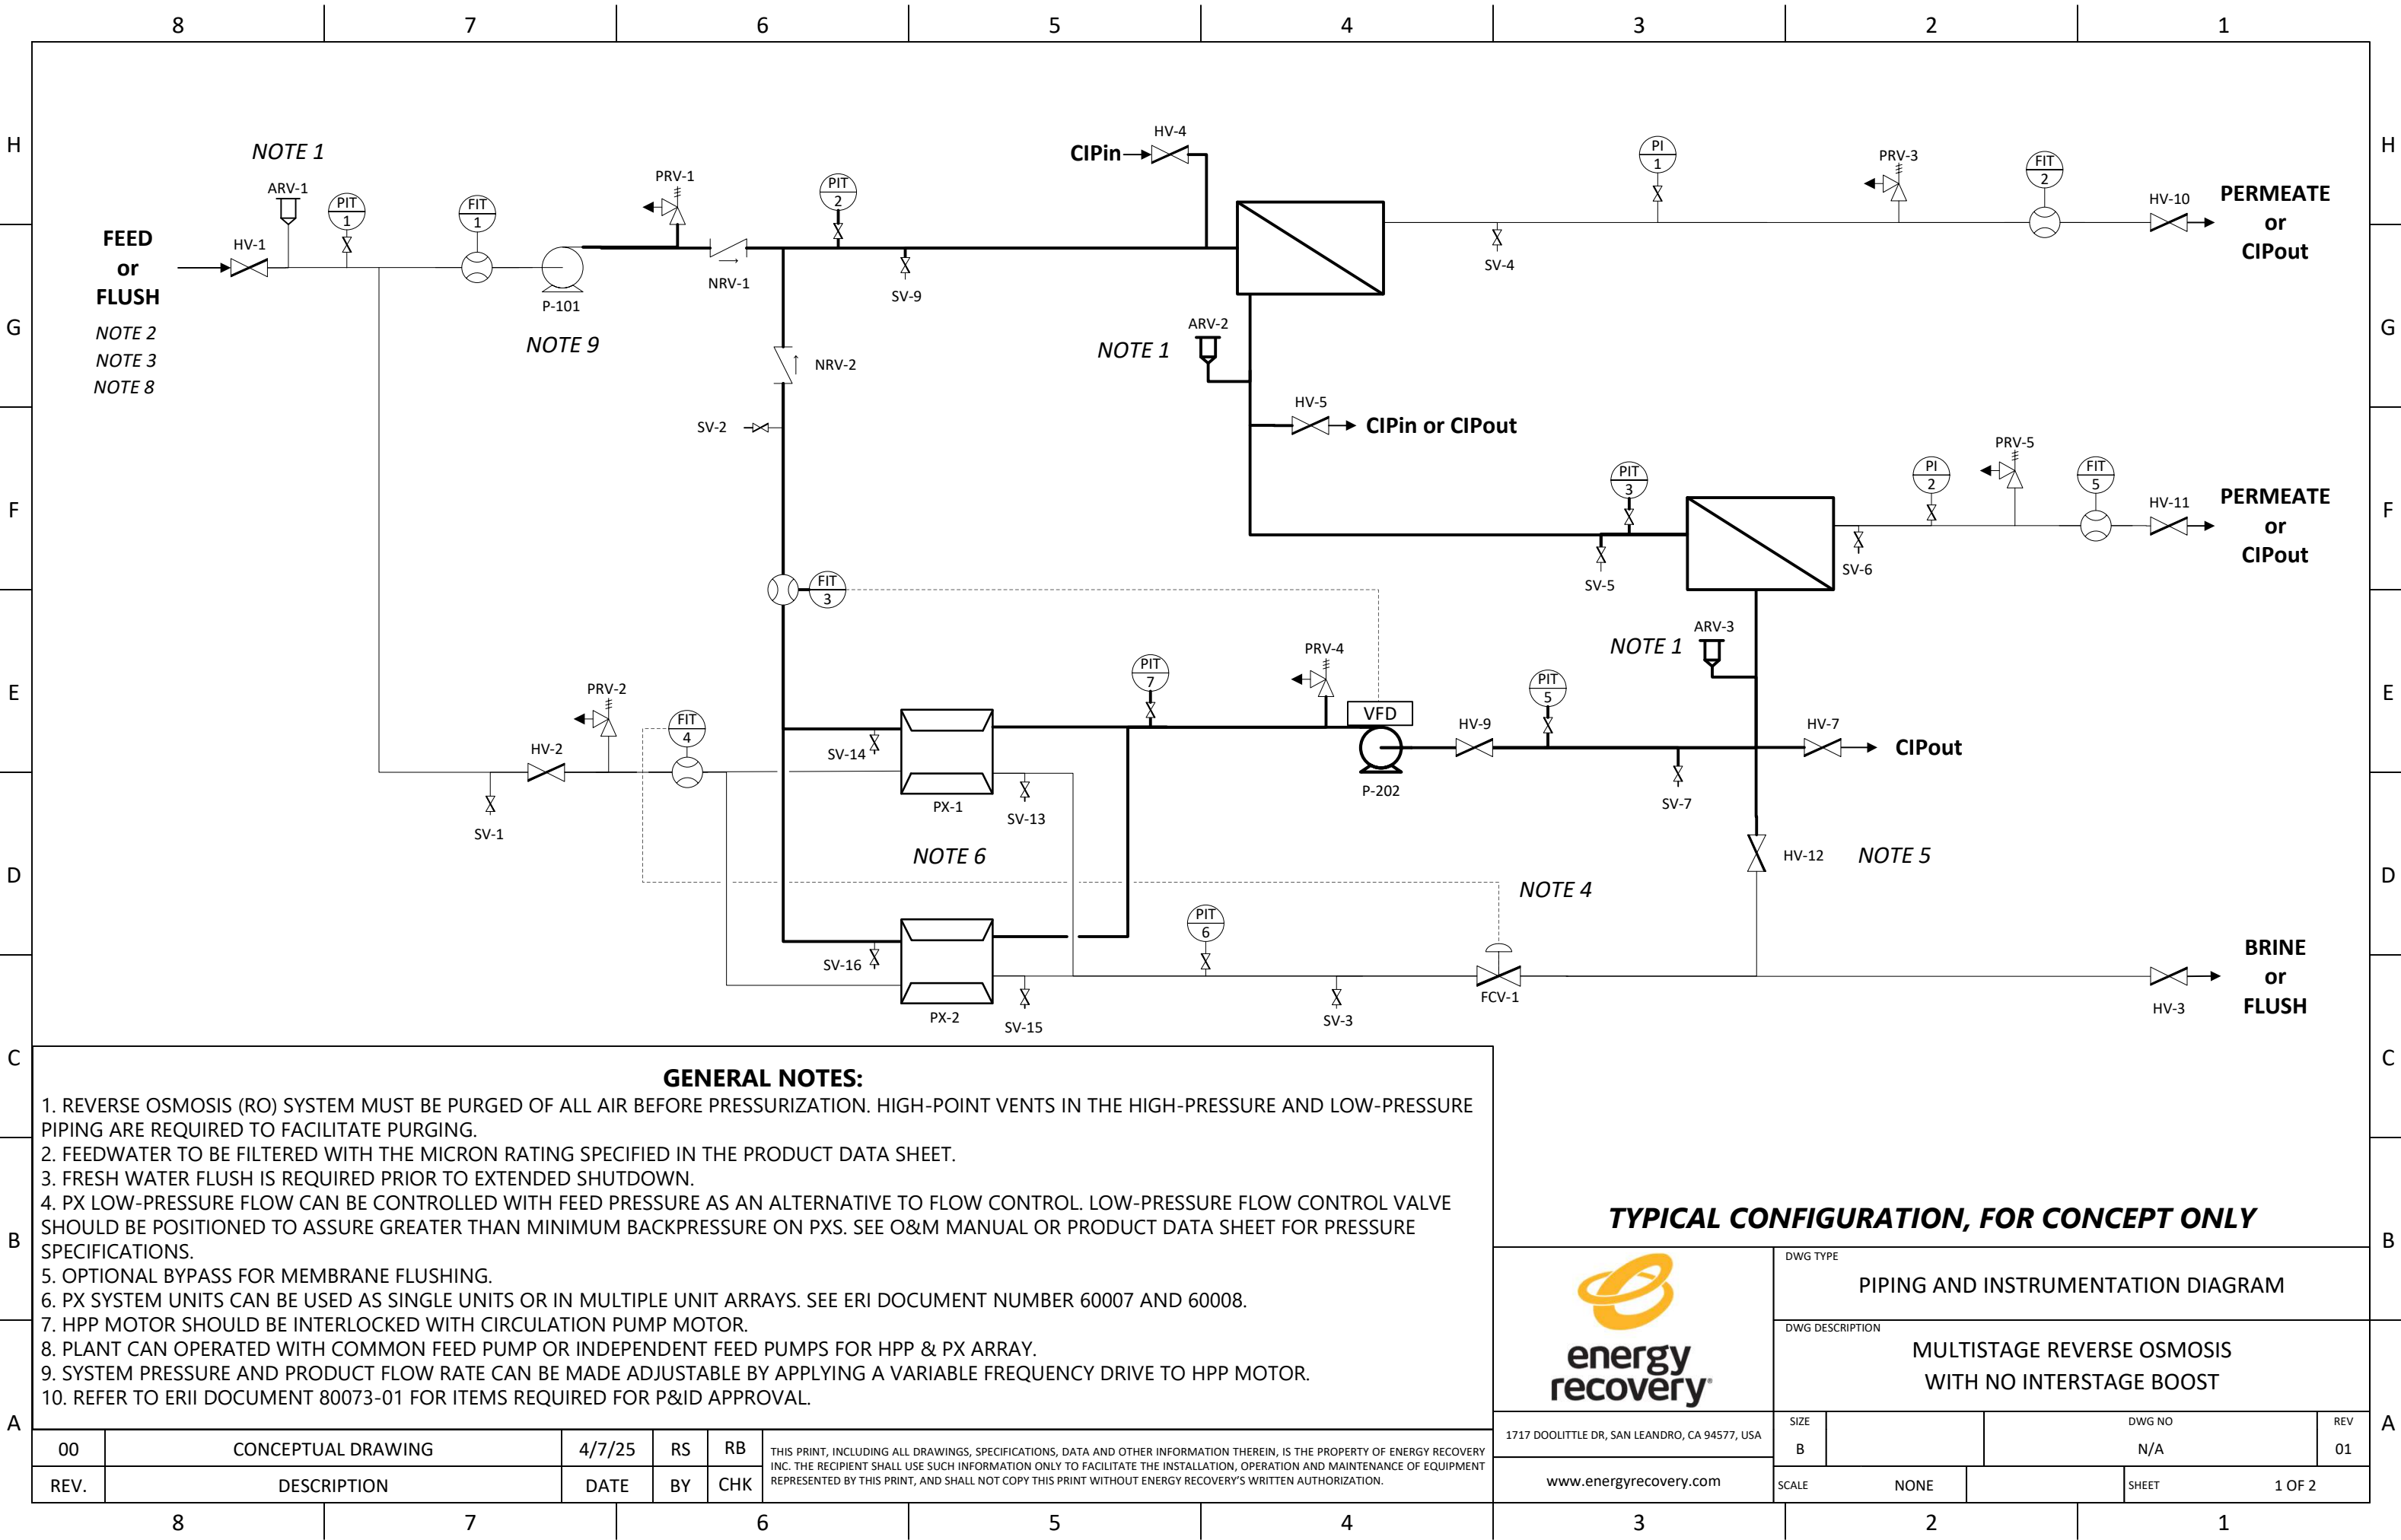


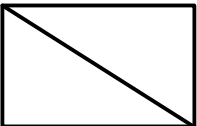

SYMBOLS

	ON-OFF VALVE
	CHECK VALVE
	CONTROL VALVE
	PRESSURE RELIEF VALVE
	SAMPLE VALVE
	AIR RELIEF VALVE
	FLOW METER
	INDICATOR OR TRANSMITTER
	REVERSE OSMOSIS MEMBRANE ARRAY
	PRESSURE EXCHANGER DEVICE
	PUMP



ON-OFF VALVE

CHECK VALVE

CONTROL VALVE

PRESSURE RELIEF VALVE

SAMPLE VALVE

AIR RELIEF VALVE

 
FLOW METER

INDICATOR OR TRANSMITTER

REVERSE OSMOSIS MEMBRANE ARRAY

PRESSURE EXCHANGER DEVICE

PUMP



DWG TYPE	PIPING AND INSTRUMENTATION DIAGRAM
DWG DESCRIPTION	MULTISTAGE REVERSE OSMOSIS WITH AND WITHOUT INTERSTAGE BOOST - SYMBOLS

1717 DOOLITTLE DR, SAN LEANDRO, CA 94577, USA	SIZE B		DWG NO N/A	
www.energyrecovery.com	SCALE	NONE	SHEET	2 OF 2

THIS PRINT, INCLUDING ALL DRAWINGS, SPECIFICATIONS, DATA AND OTHER INFORMATION THEREIN, IS THE PROPERTY OF ENERGY RECOVERY INC. THE RECIPIENT SHALL USE SUCH INFORMATION ONLY TO FACILITATE THE INSTALLATION, OPERATION AND MAINTENANCE OF EQUIPMENT REPRESENTED BY THIS PRINT, AND SHALL NOT COPY THIS PRINT WITHOUT ENERGY RECOVERY'S WRITTEN AUTHORIZATION.